

FIRST FLOOR PLAN  
OPTION -1

**CLIENT :**  
NABARD Financial Services Ltd.  
No. 3072, 14th Cross, BSK  
2nd stage, Bengaluru

**JOB TITLE :**  
INTERIOR WORKS FOR FIRST FLOOR  
ADDITIONAL PREMISES OF NABFINS  
HO.at No. 3073,  
14th Cross, BSK 2nd stage,  
Bengaluru

**ARCHITECTS :**  
**KAREKAR & ASSOCIATES**  
# 282, GROUND FLOOR 14TH CROSS ROAD  
RMV 2ND STAGE DOLLARS COLONY  
Bengaluru

SL.NO	DESCRIPTION	NOS	
1	CABIN 1,2 TABLE 5'0"X2'6"	2	
2	DISCUSSION TABLE 6'0"X3'0"	1	
3	PEDESTALS 1'6"X1'6"	40	<input checked="" type="checkbox"/>
4	LINEAR WORKSTATIONS 4'0"x2'0"	36	
5	EXECUTIVE CHAIRS	3	
6	OFFICE CHAIRS	42	
7	STORAGE 1500X450X1200 ht	5	
8	STORAGE -1 900X450X2100 ht	13	
9	FULL HEIGHT GLASS PARTITIONS AND GYPSUM		
10	SEMI HIEGHT PARTITIONS		
	FULL HT GYPSUM PARTITIONS		

**PLEASE NOTE**  
MEASUREMENTS NEED TO BE  
CHECKED AND MARKED ACCORDING  
TO SITE MEASUREMENTS

**REV NO DATE DESCRIPTION**

**DRAWING ISSUED FOR :**

APPROVAL :

TENDER :

INFORMATION :

EXECUTION :

## INTERIOR

### DRAWING :

 
 



INTERIOR LAYOUT OF FIRST FLOOR

- SCALE : • DEALT : RICHA
- DATE : 04-04-2024 • DRAWN : RICHA
- ISSUED : • CHECKED :


**DRAWING NO :01**

NABfins /BLR / 1 / 1st floor / 1 / 01 / V2

**SHEET NO : 01**

SL.NO	DESCRIPTION	NOS	
1	CABIN 1,2,3 TABLE 5'0"X2'6"	3	
2	PEDESTALS 1'6"X1'6"	40	<input checked="" type="checkbox"/>
3	LINEAR WORKSTATIONS 4'0"x2'0"	36	
4	EXECUTIVE CHAIRS	3	
5	OFFICE CHAIRS	42	
6	STORAGE 1500X450x1200 ht	5	
7	STORAGE -1 900X450x2100 ht	13	
8	FULL HEIGHT GLASS PARTITIONS AND GYPSUM		
9	SEMI HIEGHT PARTITIONS		
10	FULL HT GYPSUM PARTITIONS		

**PLEASE NOTE**  
MEASUREMENTS NEED TO BE  
CHECKED AND MARKED ACCORDING  
TO SITE MEASUREMENTS

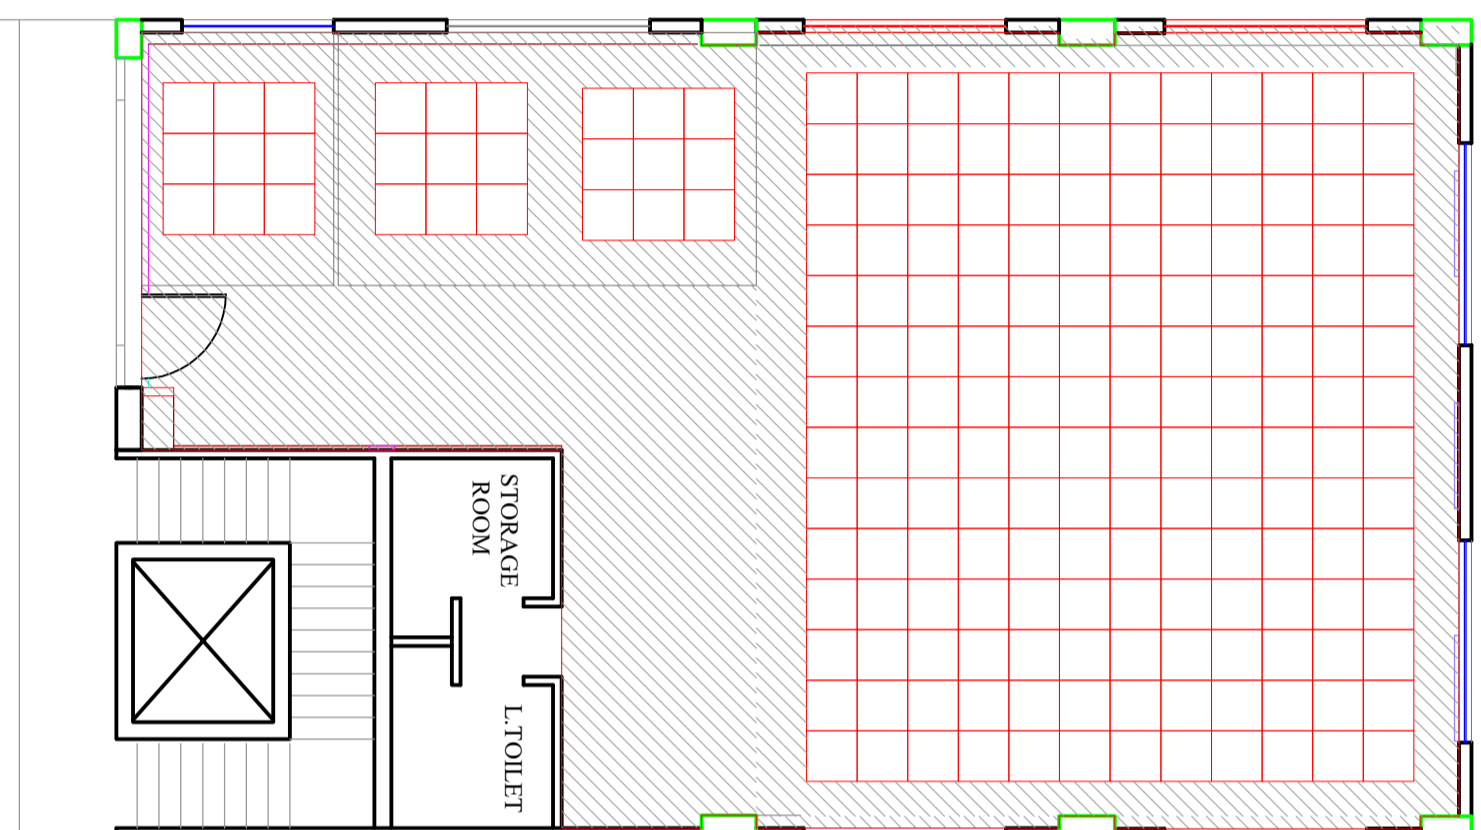


FIRST FLOOR PLAN  
OPTION -1

**CLIENT :**  
NABARD Financial Services Ltd.  
No. 3072, 14th Cross, BSK  
2nd stage, Bengaluru

**JOB TITLE :**  
INTERIOR WORKS FOR FIRST FLOOR  
ADDITIONAL PREMISES OF NABFINS  
HO.at No. 3073,  
14th Cross, BSK 2nd stage,  
Bengaluru

 **ARCHITECTS :**  
**KAREKAR & ASSOCIATES**  
# 282,GROUND FLOOR 14TH CROSS ROAD  
RMV 2ND STAGE DOLLARS COLONY  
Bengaluru

REV NO	DATE	DESCRIPTION
<b>DRAWING ISSUED FOR :</b>		
APPROVAL :	<input type="checkbox"/>	
TENDER :		
INFORMATION :	<input type="checkbox"/>	
EXECUTION :	<input type="checkbox"/>	

## INTERIOR

### DRAWING :


#### INTERIOR LAYOUT OF FIRST FLOOR

- SCALE :  DEALT : RICHHA
- DATE : 06-03-2024 • DRAWN : RICHHA
- ISSUED :  CHECKED:

#### DRAWING NO :01

NABfins /BLR / I / 1st floor / 1 / 01 / V2

#### SHEET NO : 01

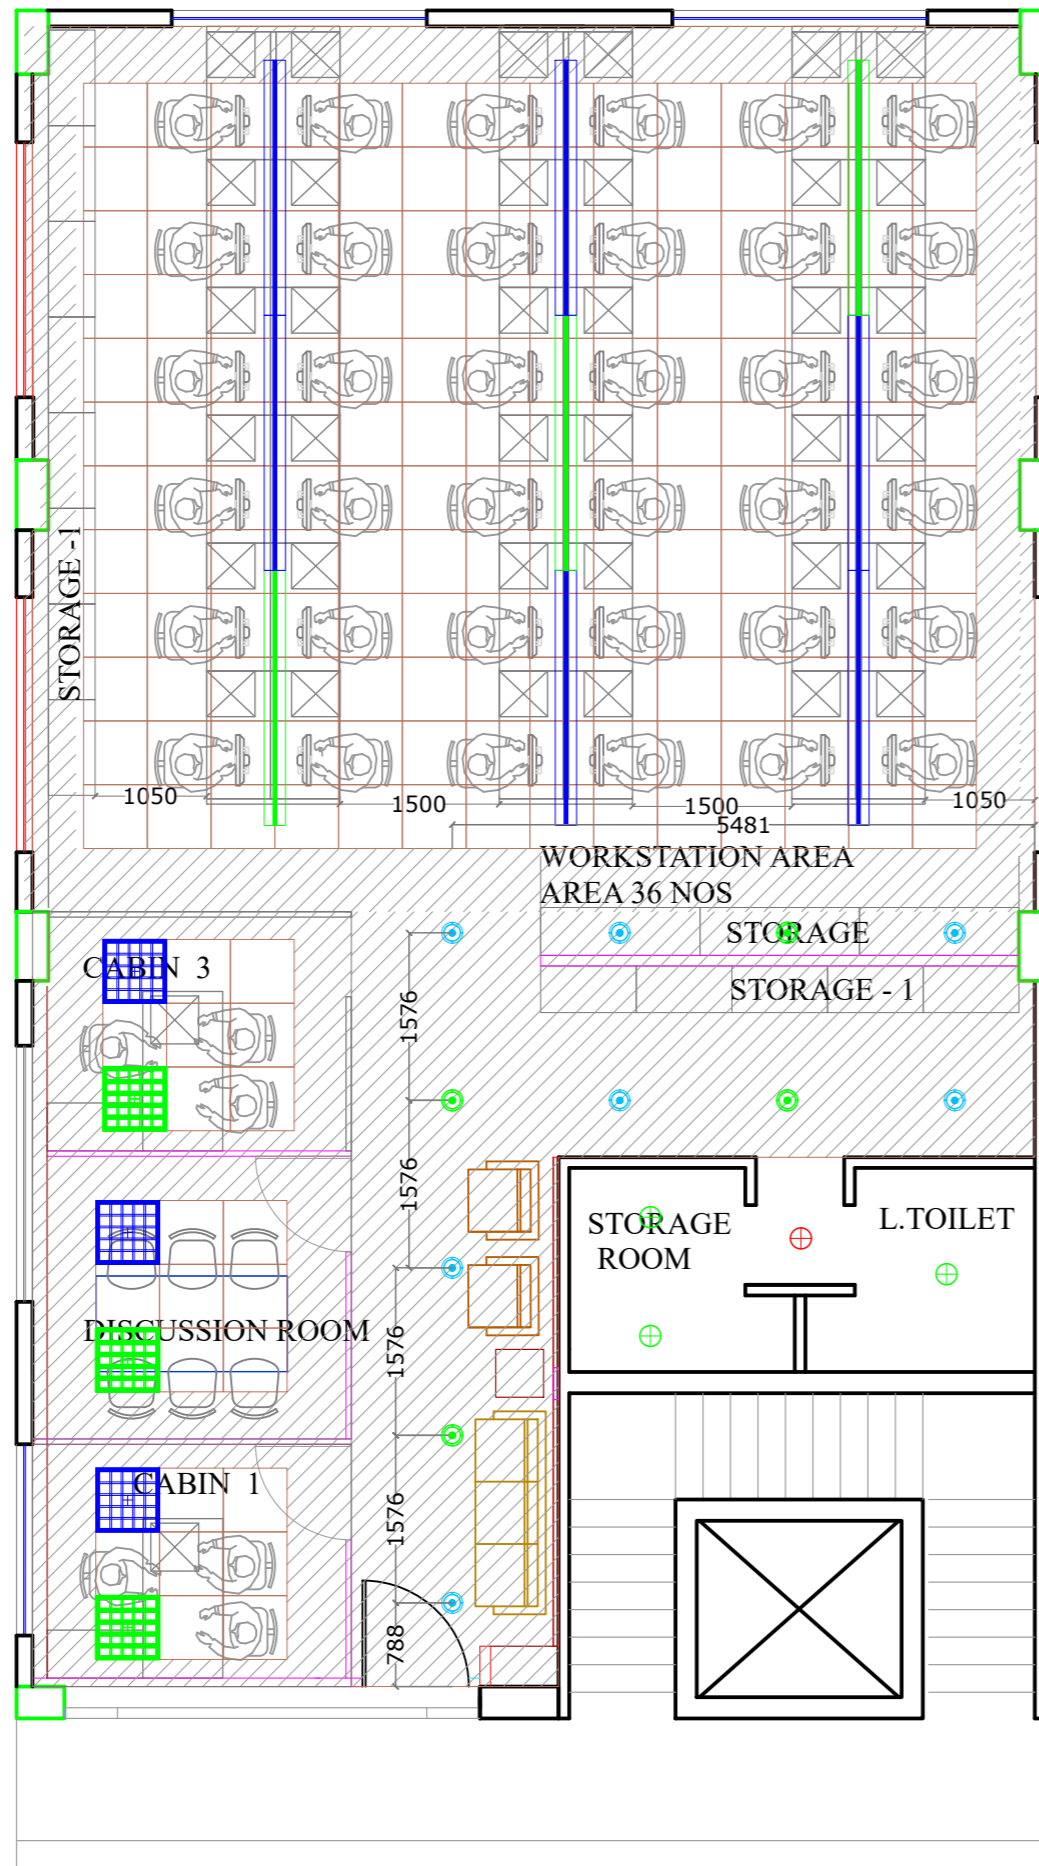

FIRST FLOOR LIGHTING PLAN

SL.NO	DESCRIPTION	NOS	
1	36W LED1 LIGHT ON RAW POWER PHILIPS RC380B LED36S 6500G6 L60W60 PSU OD	3	
2	36W LED1 LIGHT ON UPS PHILIPS RC380B LED36S 6500G6 L60W60 PSU OD	3	
3	18W LED2 LIGHT ON RAW POWER PHILIPS DURA SLIM LED DOWNLIGHT	7	
4	18W LED2 LIGHT ON UPS PHILIPS DURA SLIM LED DOWNLIGHT	7	
5	40W LED3 LINEAR LIGHT 8FEET ON RAW POWER SP780 H LED50S 6500 PSU W5L224 OD WH	6	
6	40W LED3 LINEAR LIGHT 8FEET ON UPS SP780 H LED50S 6500 PSU W5L224 OD WH	3	
7	12W LED4 LIGHT ON RAW POWER PHILIPS STAR SURFACE 12W ROUND LED DOWLIGHTER WHITE	1	
8	12W LED4 LIGHT ON UPS PHILIPS STAR SURFACE 12W ROUND LED DOWLIGHTER WHITE	3	

**CLIENT :**  
 NABARD Financial Services Ltd.  
 No. 3072, 14th Cross, BSK  
 2nd stage, Bengaluru

**JOB TITLE :**  
 INTERIOR WORKS FOR FIRST FLOOR  
 ADDITIONAL PREMISES OF NABFINS  
 HO.at No. 3073,  
 14th Cross, BSK 2nd stage,  
 Bengaluru

**ARCHITECTS :**  
**KAREKAR & ASSOCIATES**  
 # 282,GROUND FLOOR 14TH CROSS ROAD  
 RMV 2ND STAGE DOLLARS COLONY

REV NO	DATE	DESCRIPTION

**DRAWING ISSUED FOR :**

APPROVAL :	
TENDER :	
INFORMATION :	
EXECUTION :	

**ELECTRICAL**


**DRAWING :**  
 LIGHTING PLAN

- SCALE :
- DEALT : AJAY
- DATE : 04-04-2024
- DRAWN : AJAY
- ISSUED : 17-04-2024
- CHECKED: SHAKIB

**DRAWING NO :**

NABFINS /BLR / ELE / 1st floor / LIGHITNG/1 / 01 / V1

**SHEET NO : 01**

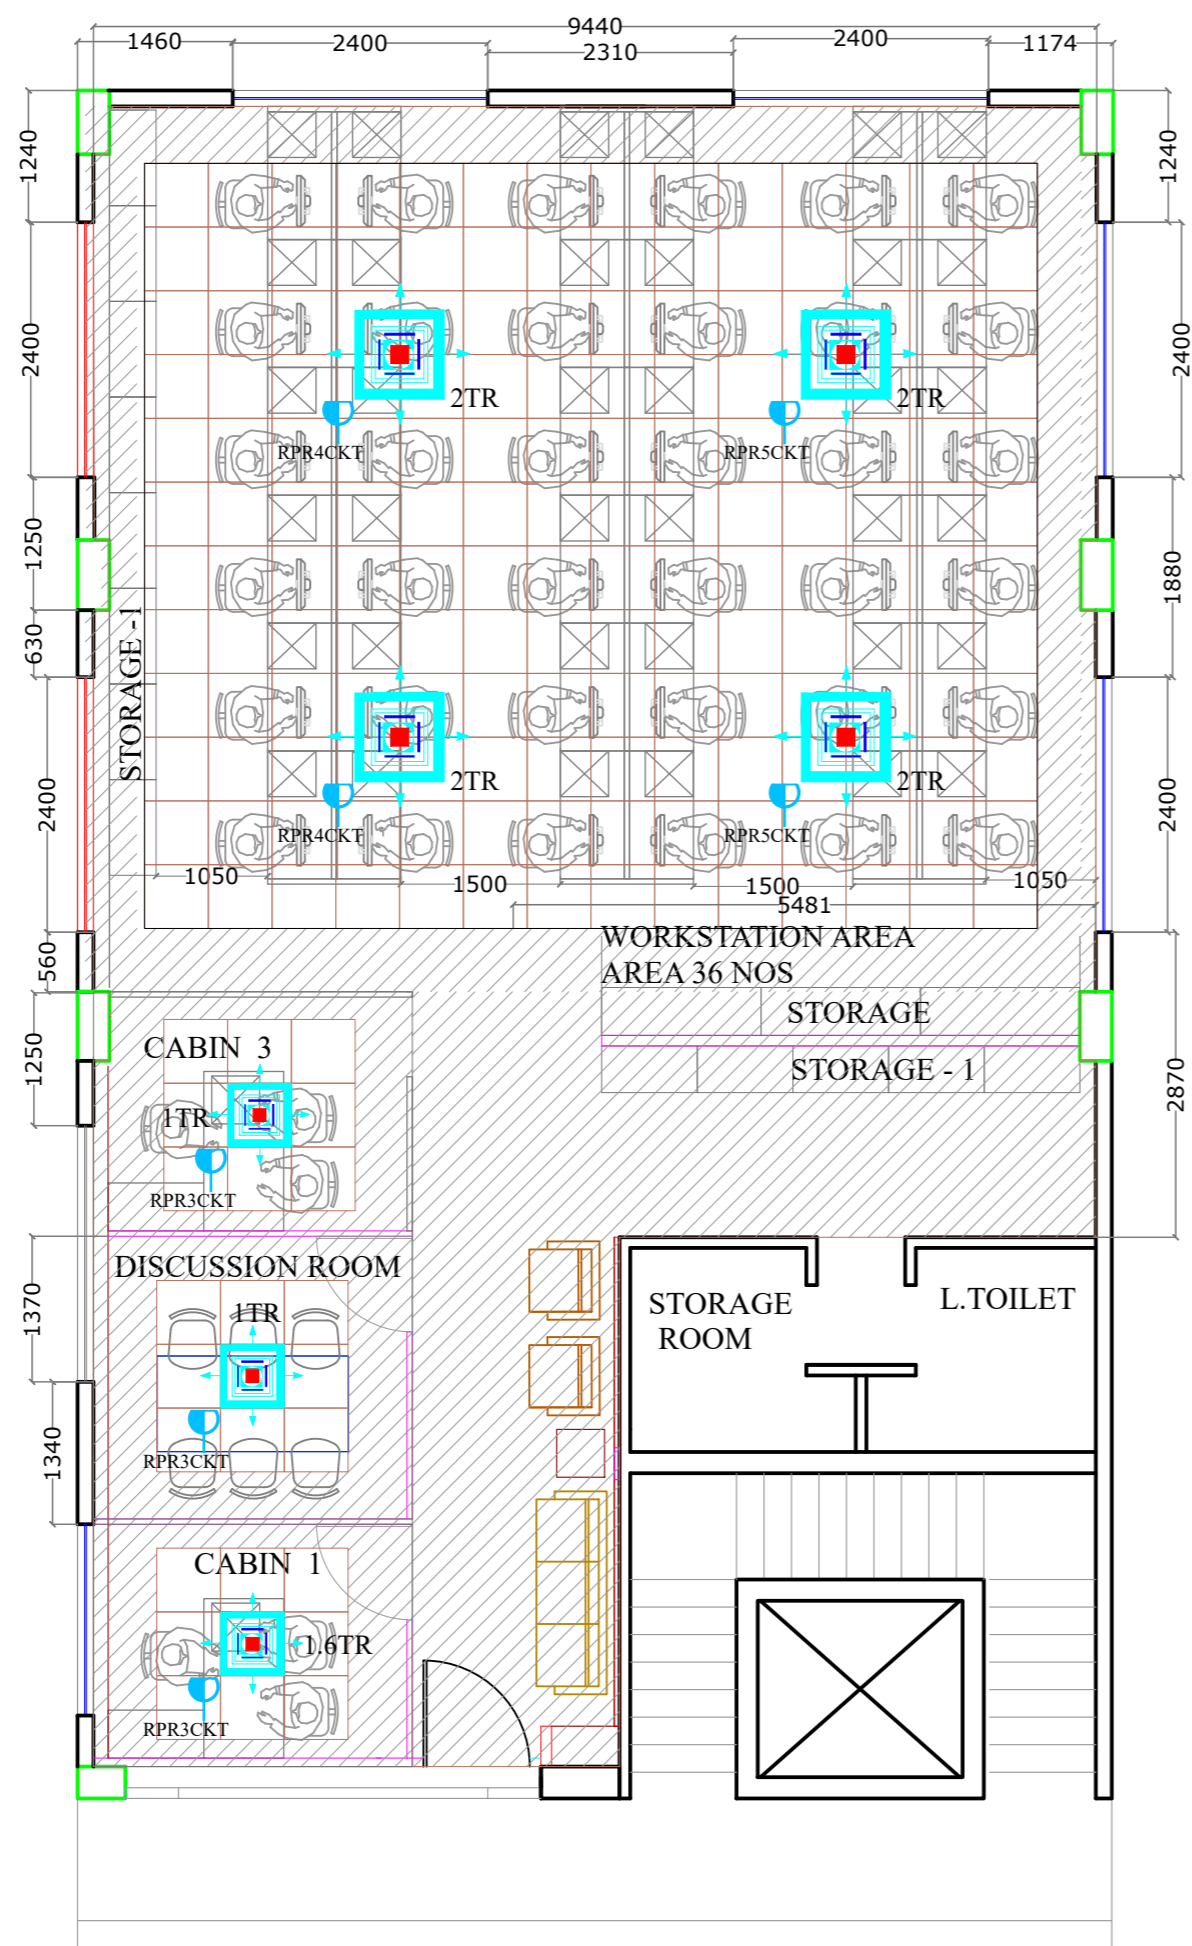

FIRST FLOOR AC PLAN

**CLIENT :**  
NABARD Financial Services Ltd.  
No. 3072, 14th Cross, BSK  
2nd stage, Bengaluru

**JOB TITLE :**  
INTERIOR WORKS FOR FIRST FLOOR  
ADDITIONAL PREMISES OF NABFINS  
HO.at No. 3073,  
14th Cross, BSK 2nd stage,  
Bengaluru

**ARCHITECTS :**  
**KAREKAR & ASSOCIATES**  
# 282,GROUND FLOOR 14TH CROSS ROAD  
RMV 2ND STAGE DOLLARS COLONY

REV NO	DATE	DESCRIPTION
<b>DRAWING ISSUED FOR :</b>		
APPROVAL :	<input type="text"/>	
TENDER :	<input type="text"/>	
INFORMATION :	<input type="text"/>	
EXECUTION :	<input type="text"/>	

**AIR CONDITIONING**

**DRAWING :**

AIR CONDITIONING PLAN

• SCALE :                      • DEALT : AJAY


• DATE : 04-04-2024      • DRAWN : AJAY

• ISSUED : 17-04-2024    • CHECKED: SHAKIB

**DRAWING NO :**

NABfins /BLR / AC / 1st floor /AIR COND/ 1 / 02 / V1

**SHEET NO : 02**

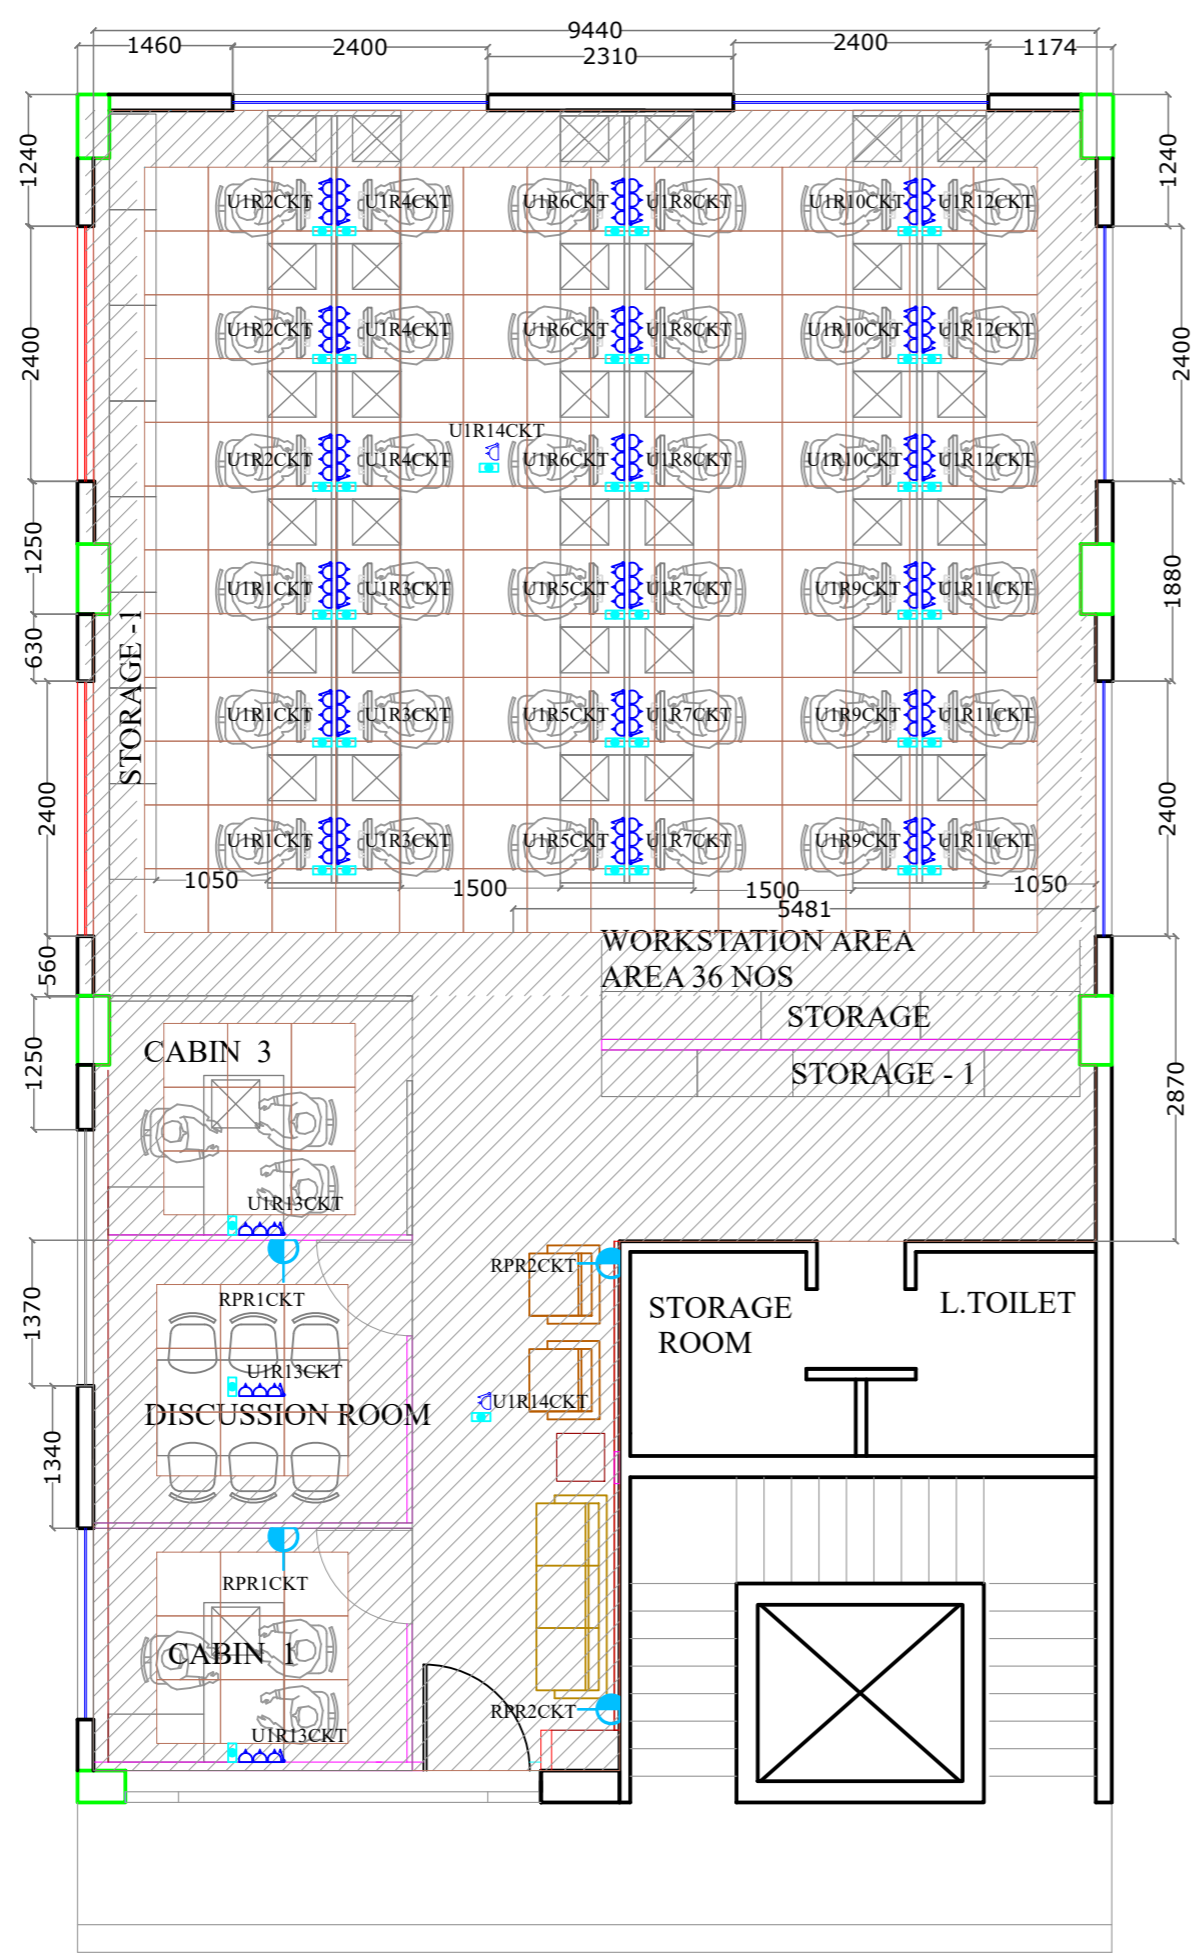

FIRST FLOOR POWER PLAN

SL.NO	DESCRIPTION	NOS	
1	3Nos OF 6A SOCKETS CONTROLLED BY 1No OF 16A SWITCH	39	
2	1No OF 6A SOCKETS CONTROLLED BY 1No OF 6A SWITCH	2	
3	1No OF RJ45 OUTLET	41	
4	1No OF 16A SOCKETS CONTROLLED BY 1No OF 16A SWITCH	4	

**CLIENT :**  
 NABARD Financial Services Ltd.  
 No. 3072, 14th Cross, BSK  
 2nd stage, Bengaluru

**JOB TITLE :**  
 INTERIOR WORKS FOR FIRST FLOOR  
 ADDITIONAL PREMISES OF NABFINS  
 HO.at No. 3073,  
 14th Cross, BSK 2nd stage,  
 Bengaluru

**ARCHITECTS :**  
**KAREKAR & ASSOCIATES**  
 # 282,GROUND FLOOR 14TH CROSS ROAD  
 RMV 2ND STAGE DOLLARS COLONY

REV NO	DATE	DESCRIPTION

DRAWING ISSUED FOR :

APPROVAL :	
TENDER :	
INFORMATION :	
EXECUTION :	

**ELECTRICAL**


**DRAWING :**  
 POWER PLAN

• SCALE :	• DEALT : AJAY
• DATE : 04-04-2024	• DRAWN : AJAY
• ISSUED : 17-04-2024	• CHECKED: SHAKIB

**DRAWING NO :01**

NABfins /BLR / ELE / 1st floor /POWER/ 1 / 03 / V1

**SHEET NO : 03**

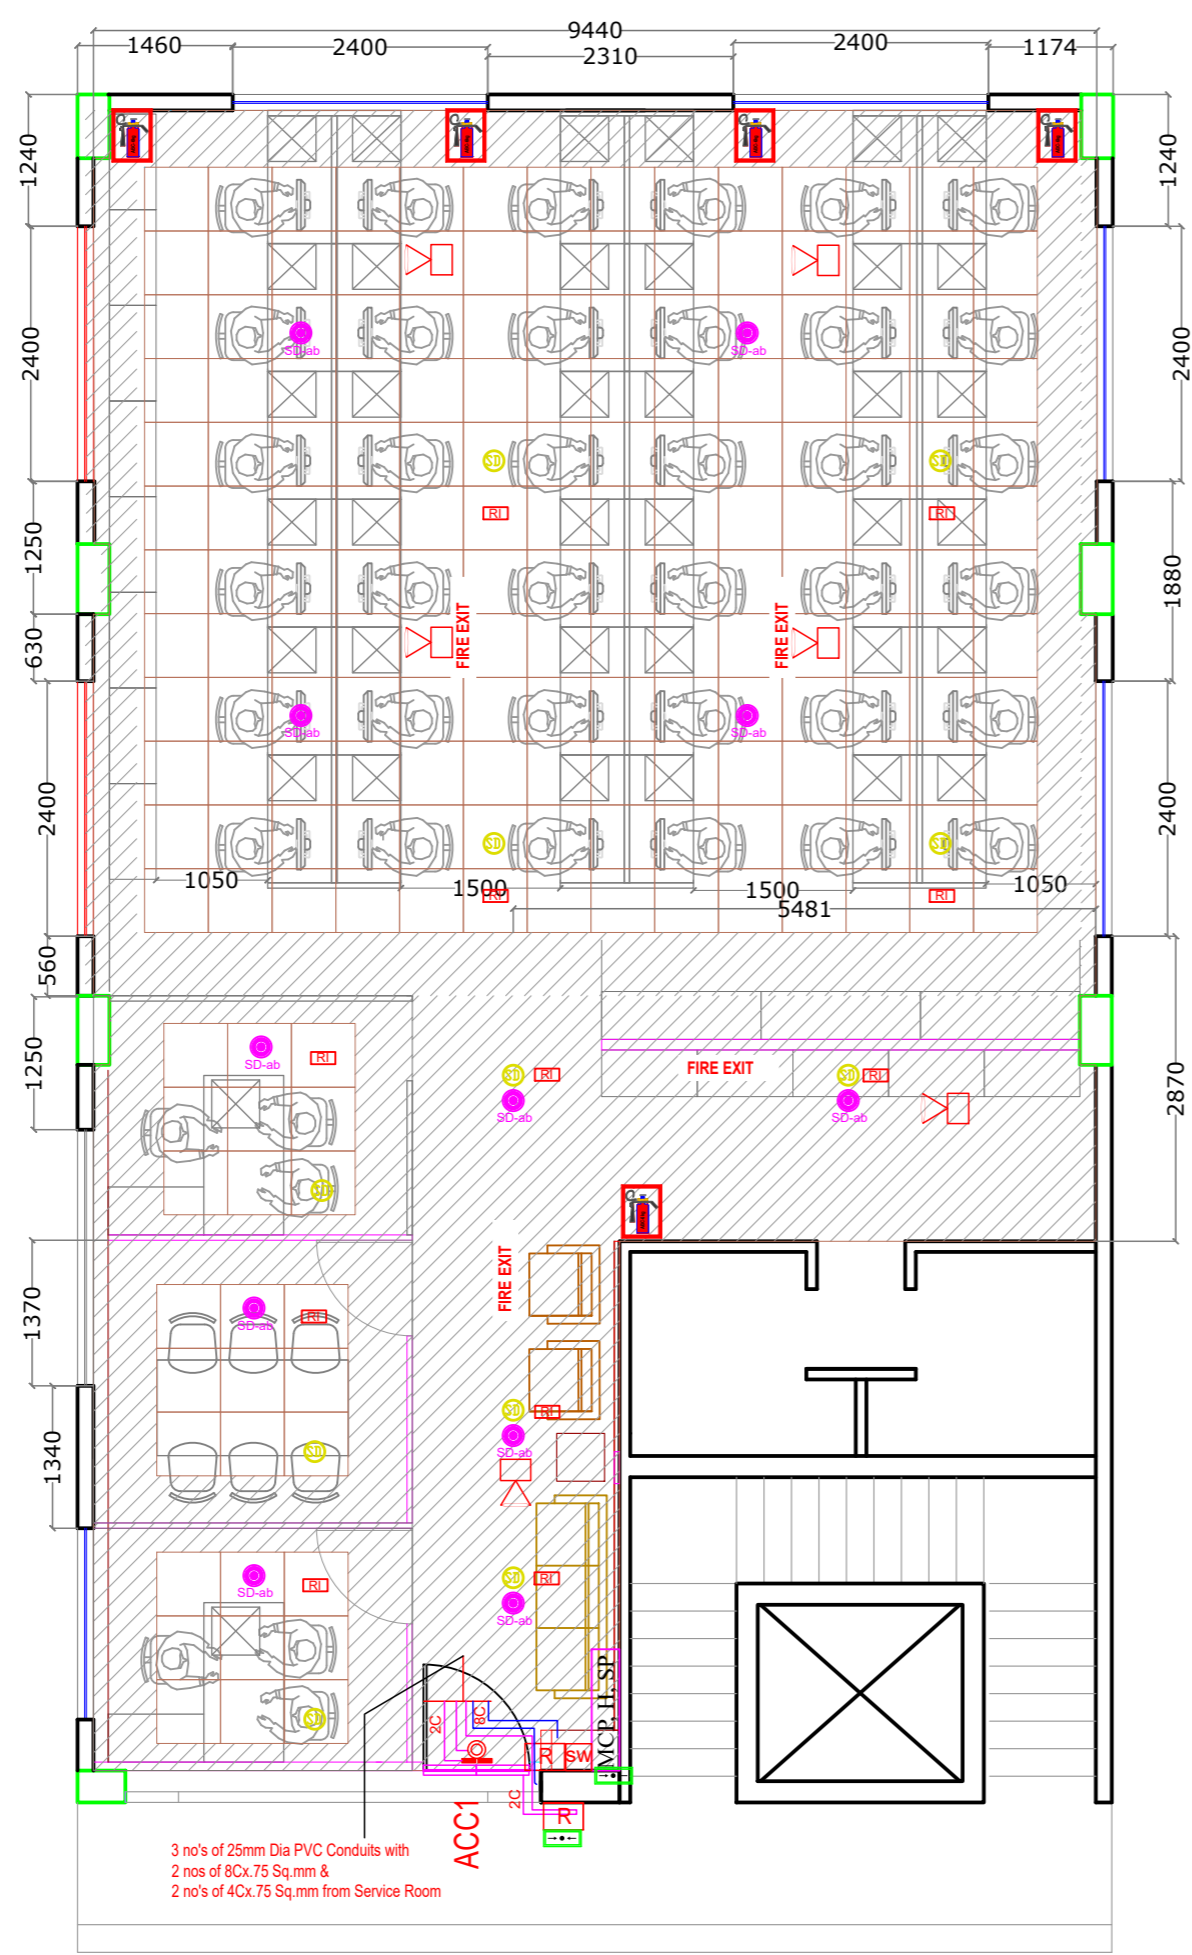

**FIRST FLOOR FIRE ALARM,  
PUBLIC ADDRESS & ACCESS  
CONTROL PLAN**

SL.NO	DESCRIPTION	NOS	
1	MULTISENSOR DETECTOR ABOVE FALSE CEILING	11	
2	MULTISENSOR DETECTOR ON FALSE CEILING	11	
3	6WATT CEILING SPEAKER	6	
4	RESPONSE INDICATOR	11	
5	6KG ABC EXTINGUISHER	5	

**CLIENT :**  
 NABARD Financial Services Ltd.  
 No. 3072, 14th Cross, BSK  
 2nd stage, Bengaluru

**JOB TITLE :**  
 INTERIOR WORKS FOR FIRST FLOOR  
 ADDITIONAL PREMISES OF NABFINS  
 HO.at No. 3073,  
 14th Cross, BSK 2nd stage,  
 Bengaluru

**ARCHITECTS :**  
**KAREKAR & ASSOCIATES**  
 # 282,GROUND FLOOR 14TH CROSS ROAD  
 RMV 2ND STAGE DOLLARS COLONY

REV NO	DATE	DESCRIPTION
<b>DRAWING ISSUED FOR :</b>		
APPROVAL :		
TENDER :		
INFORMATION :		
EXECUTION :		


**LOW VOLTAGE SYSTEM**

**DRAWING :**  
 FIRE ALARM,PUBLIC ADDRESS & ACCESS

• SCALE :	• DEALT : AJAY
• DATE : 04-04-2024	• DRAWN : AJAY
• ISSUED : 17-04-2024	• CHECKED: SHAKIB

**DRAWING NO :**  
 NABfins /BLR /LV / 1st floor / LV/1 / 04 / V1

**SHEET NO : 04**

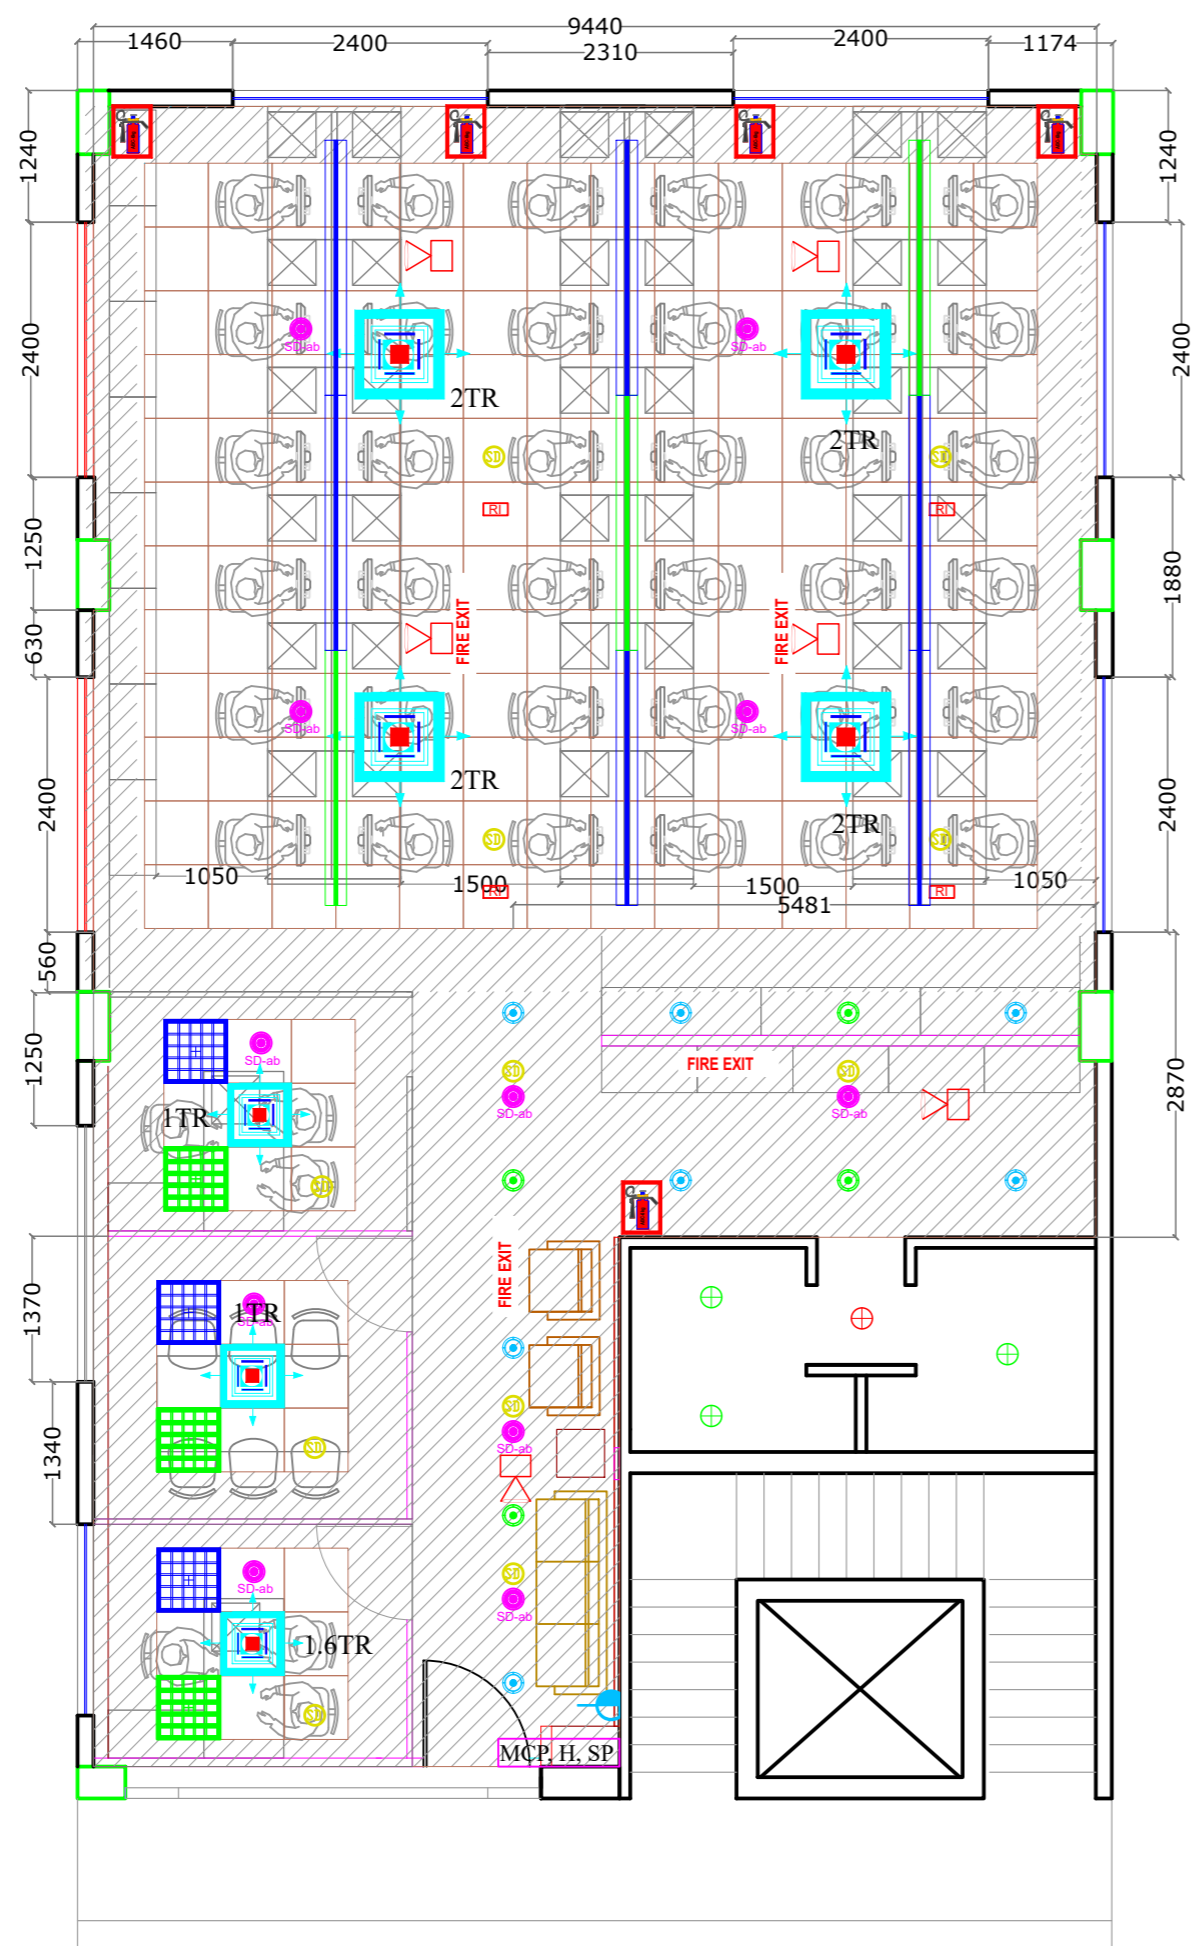

**FIRST FLOOR FIRE ALARM, PUBLIC ADDRESS & ACCESS CONTROL PLAN**

**CLIENT :**  
 NABARD Financial Services Ltd.  
 No. 3072, 14th Cross, BSK  
 2nd stage, Bengaluru

**JOB TITLE :**  
 INTERIOR WORKS FOR FIRST FLOOR  
 ADDITIONAL PREMISES OF NABFINS  
 HO.at No. 3073,  
 14th Cross, BSK 2nd stage,  
 Bengaluru

**ARCHITECTS :**  
**KAREKAR & ASSOCIATES**  
 # 282,GROUND FLOOR 14TH CROSS ROAD  
 RMV 2ND STAGE DOLLARS COLONY

REV NO	DATE	DESCRIPTION
--------	------	-------------

**DRAWING ISSUED FOR :**

APPROVAL :	<input type="text"/>
TENDER :	<input type="text"/>
INFORMATION :	<input type="text"/>
EXECUTION :	<input type="text"/>








**COORDINATION PLAN**

**DRAWING :**  
 COORDINATION DRAWING

- SCALE :
- DEALT : AJAY
- DATE : 04-04-2024
- DRAWN : AJAY
- ISSUED : 17-04-2024
- CHECKED: SHAKIB

**DRAWING NO :**  
 NABfins /BLR / I / 1st floor / 1 / 05 / V1

**SHEET NO : 05**

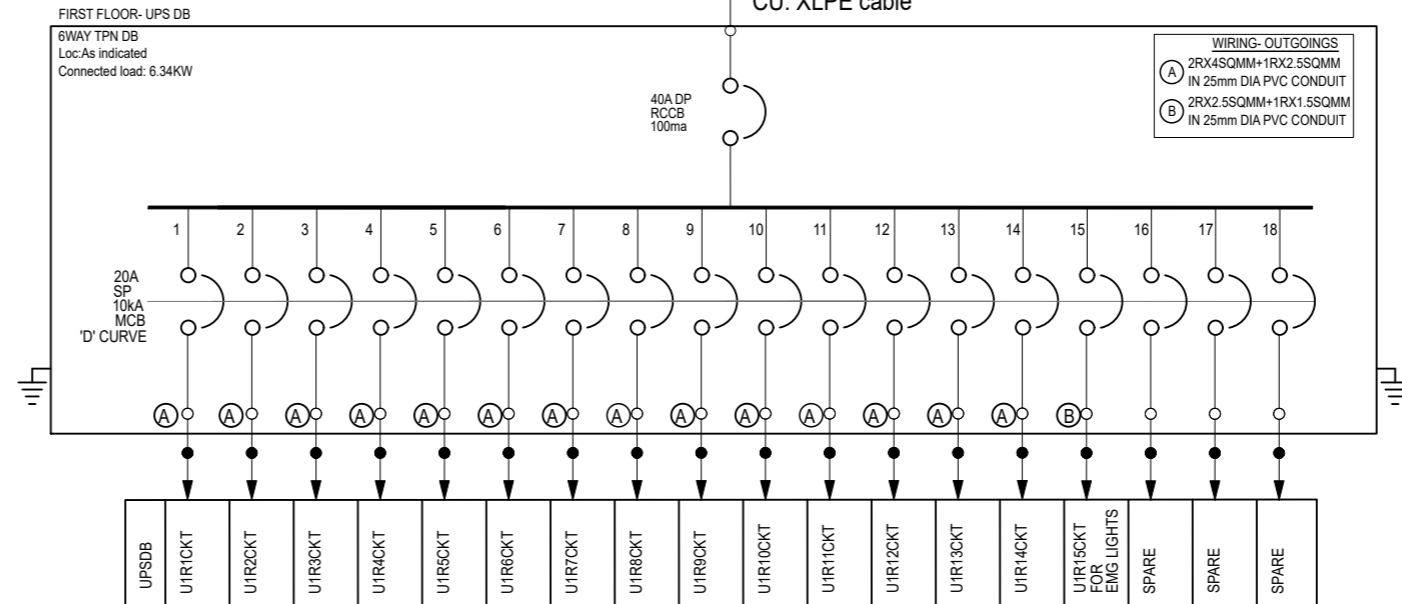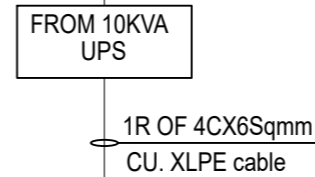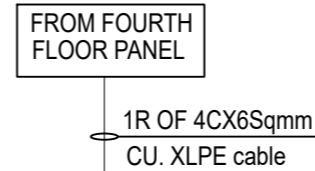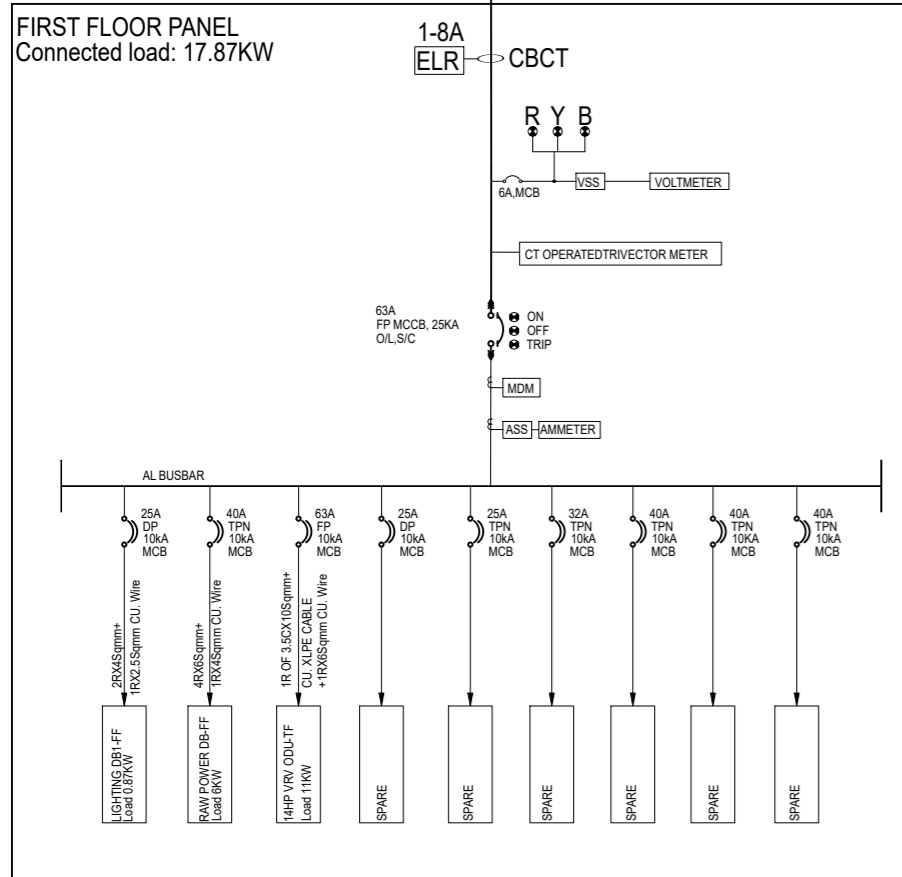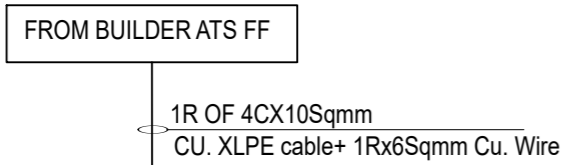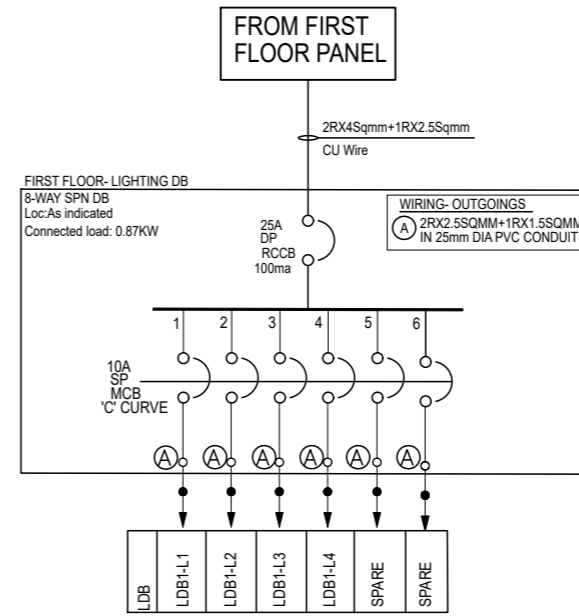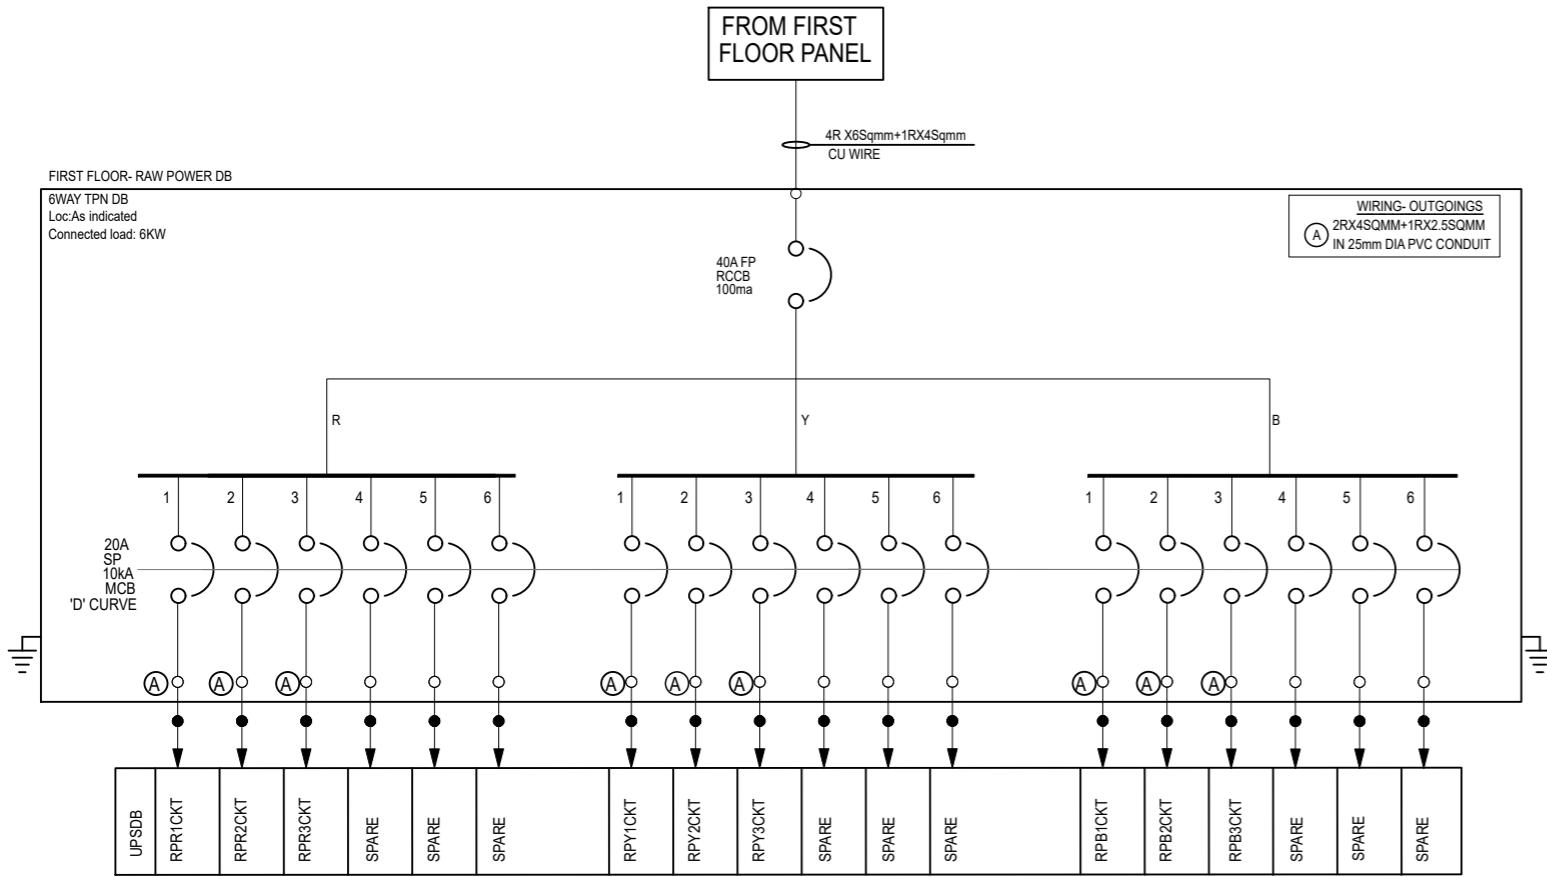

**CLIENT :**  
NABARD Financial Services Ltd.  
No. 3072, 14th Cross, BSK  
2nd stage, Bengaluru

**JOB TITLE :**  
INTERIOR WORKS FOR FIRST FLOOR  
ADDITIONAL PREMISES OF NABFINS  
HO.at No. 3073,  
14th Cross, BSK 2nd stage,  
Bengaluru

**ARCHITECTS :**  
**KAREKAR & ASSOCIATES**  
# 282,GROUND FLOOR 14TH CROSS ROAD  
RMV 2ND STAGE DOLLARS COLONY

REV NO	DATE	DESCRIPTION

**DRAWING ISSUED FOR :**

APPROVAL :	<input type="text"/>
TENDER :	<input checked="" type="checkbox"/>
INFORMATION :	<input type="text"/>
EXECUTION :	<input type="text"/>

## ELECTRICAL

**DRAWING :**  
SINGLE LINE DIAGRAM & DB SCHEMATIC

• SCALE :	• DEALT : AJAY
• DATE : 04-04-2024	• DRAWN : AJAY
• ISSUED : 17-04-2024	• CHECKED: SHAKIB

**DRAWING NO :**

NABfins /BLR / ELE / 1st floor / SLD/1 / 06 / V1

**SHEET NO : 06**